


NOTES

- THIS DRAWING SHALL BE READ IN CONJUNCTION WITH THE CONTRACT DRAWINGS AND SPECIFICATION
- SETOUT OF ROAD CENTERLINE, FACE OF KERB AND EDGE OF SEAL FOR UN-KERBED ROADS SHALL BE BASED ON SUPPLIED AUTOCAD DATA. ALL OTHER WORKS SHALL BE SETOUT BASED ON INFORMATION CONTAINED ON THE CONTRACT DRAWINGS
- THE CONSTRUCTION OF WORKS SHALL BE TO THE APPROVAL OF THE LOCAL AUTHORITY
- ALL DIMENSIONS ARE IN METRES UNLESS SHOWN OTHERWISE
- ALL LEVELS SHALL BE DETERMINED FROM BENCHMARKS ESTABLISHED BY THE PROJECT SURVEYOR
- ALL TRENCHING, PIPE BEDDING AND BACKFILLING SHALL BE IN ACCORDANCE WITH AS3725
- ALL DRAINAGE PITS SHALL BE LOCATED AS SHOWN IRRESPECTIVE OF PIPE LENGTHS SHOWN ON THE DRAWINGS
- WHERE A SEWER LINE INTERSECTS WITH STORMWATER DRAINAGE LINE AND THE SEWER PASSES OVER THE DRAIN THEN THE SEWER SHALL HAVE A TIMBER PILE AND KEEL PROVIDED FOR THE FULL EXTENT NECESSARY TO SUPPORT THE SEWER DURING EXCAVATION FOR THE DRAIN
- THE CONTRACTOR SHALL IMMEDIATELY REPORT ANY DISCREPANCY OR CLASH WITH OTHER SERVICES TO THE SUPERINTENDENT
- FOR SERVICE CROSSING LEVELS REFER TO DRAINAGE LONGITUDINAL SECTIONS
- ROAD PAVEMENT TYPES AND BRICK PAVING REMOVED FOR CLARITY - REFER TO PAVEMENT DRAWING FOR DETAILS
- IN CIRCUMSTANCES WHERE MULTIPLE PIPES ENTER A LINER A MINIMUM OF 40% OF THE LINER SHALL REMAIN IN ANY HORIZONTAL PLANE

LEGEND

- LIMIT OF WORKS
- LOT NUMBER
- PIPE DIA-CLASS GRADE
- PROPOSED LOT DRAINAGE WITH NOTATION
- CLASS (CLASS IF NOT CLASS 2)
UPSTREAM INVERT LEVEL
PIPE DIA / GRADE
LENGTH
DOWNSTREAM INVERT LEVEL
- PROPOSED LOT DRAINAGE
- EXISTING Ø250PVC OUTLET PIPE TO BE UPGRADED TO Ø300RCP
- EXISTING DRAINAGE
- ROAD DRAINAGE
- FUTURE DRAINAGE
- EXISTING DRAINAGE & CATCH PIT TO BE REMOVED
- PROPOSED JUNCTION PIT
- PROPOSED LOT CONNECTION PIT AND CONNECTIONS
- PIT TYPE
PIT NUMBER
CHAINAGE
- JUNCTION PIT
- LOT CONNECTION PIT
- GRATED PIT (TRAPPED WHEN IN SWALES)
- PROPOSED/EXISTING/FUTURE SEWER
- PROPOSED/EXISTING RETAINING WALL
- PREFERRED GARAGE LOCATION

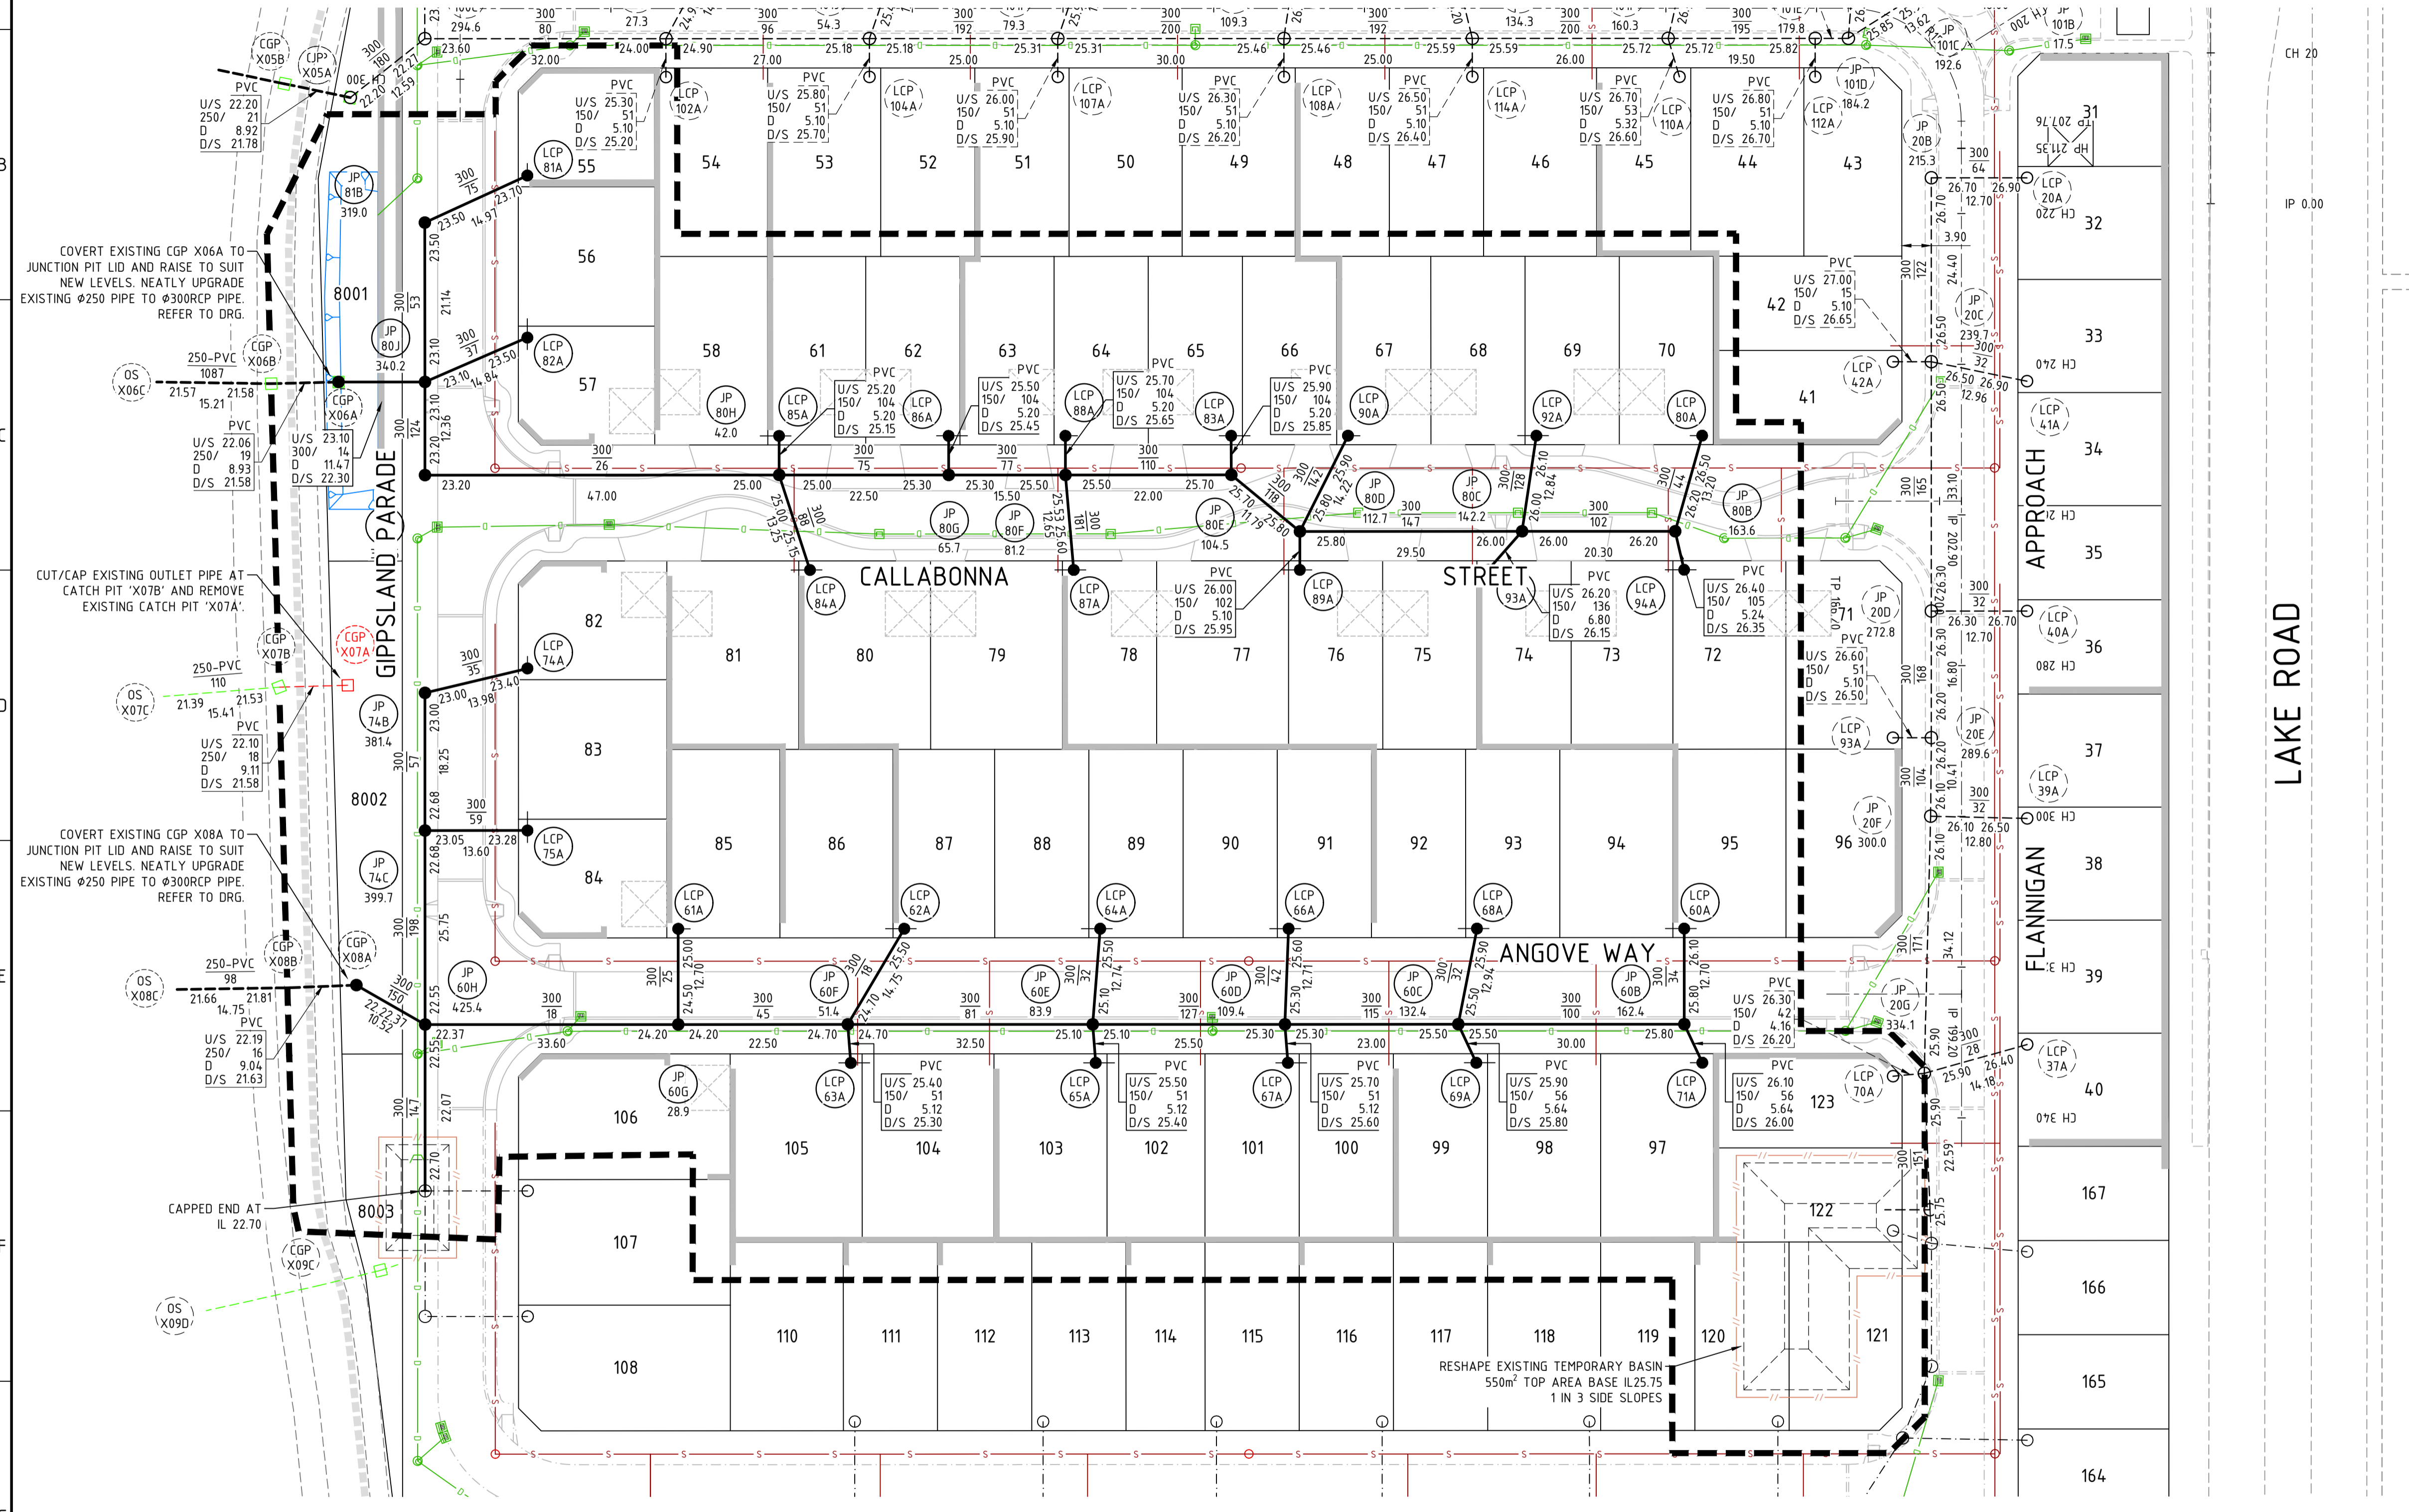

0 5 10 20 30m
SCALE 1:500 @ ORIGINAL SHEET SIZE A1

WARNING
BEWARE OF UNDERGROUND SERVICES

The location of underground cables are approximate only and their exact position should be checked on site. No guarantee is given that all existing cables and services are shown. Locate all underground cables and services before commencement of work. Refer to Work Health and Safety (General) Regulations 2022.

REV	DATE	DRAWN	CHECKED	APPROVED	
B	12/3/24	SP	BG	BSS	CALLABONNA STREET RE-DESIGNED
A	17/11/23	MS	BG	BSS	ISSUED FOR TENDER

COPYRIGHT
This drawing is copyright and the property of JDSI Pty Ltd (JDSI). Use without written permission from JDSI constitutes an infringement of copyright.
This document and the information are solely for the use of the authorised recipient and may not be used, copied or reproduced in whole or part for any purpose other than that for which it was supplied by JDSI.

NOTE
This drawing shall be preliminary only until it is issued for construction.
Certified Quality System to ISO 9001

PROJECT: WATERMARK STAGE 2
LOT 10 LAKE ROAD CHAMPION LAKES

DRAWING TITLE: LOT DRAINAGE LAYOUT

DRAWN	M SABBATINO	WAPC No.	163897
DESIGNED	M SABBATINO	SCALE	1:500
PROJECT MANAGER	B STYLE	DATUM	AHD
JDSI PROJECT No.	JDS1814.96.02	CO-ORDS	PC694
DRAWING No.	C360	REVISION	B